

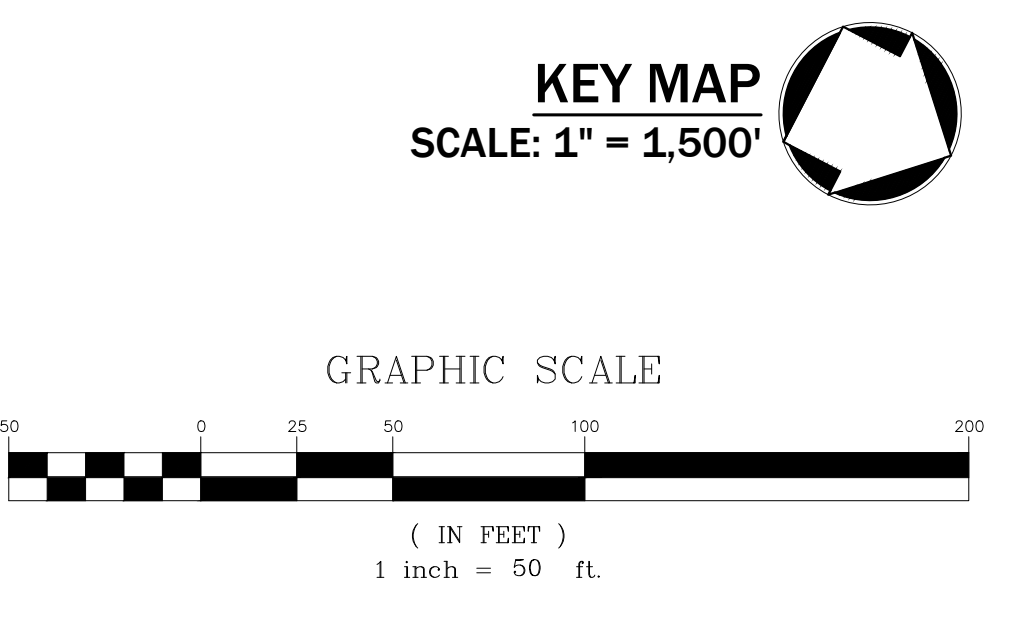


Label	Units	Avg	Max	Min	Avg/Min	Max/Min	PtSpLr	PtSpTb
BUILDING A ENTRANCE	Fc	1.91	4.5	0.1	19.10	45.00	20	20
BUILDING A PARKING	Fc	1.42	5.0	0.1	14.20	50.00		
BUILDING B ENTRANCE	Fc	1.67	4.3	0.1	16.70	43.00		
BUILDING B PARKING	Fc	1.38	5.0	0.0	N.A.	N.A.		

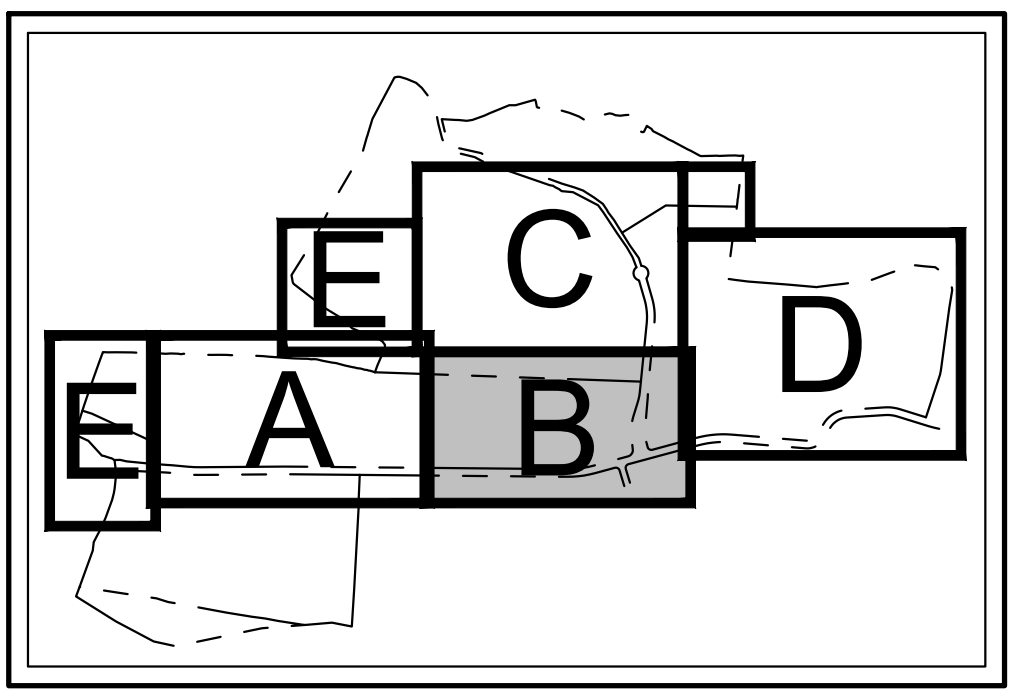

Symbol	Qty	Label	Total Lamp Lumens	LLF	Description	Lum. Watts
●	10	A	N.A.	0.950	WLS-CLXM-LED-18L-SIL-5W-50-70CRI 17' POLE 3' BASE	148.5
●	37	B	N.A.	0.950	WLS-CLXM-LED-18L-SIL-FT-50-70CRI 17' POLE 3' BASE	148.5
●	59	C	N.A.	0.950	WLS-CLXM-LED-18L-SIL-FT-50-70CRI-IL 17' POLE 3' BASE	148.5
●	2	D	N.A.	0.950	WLS-CLXM-LED-12L-SIL-2-50-70CRI 17' POLE 3' BASE	93.1
●	23	E	N.A.	0.950	WLS-CLXM-LED-12L-SIL-3-50-70CRI 17' POLE 3' BASE	93.1
■	42	F	N.A.	0.950	WLS-MIRM-FT-LED-08-50-DIM 16' MOUNTING HEIGHT	76
■	18	G	N.A.	0.950	WLS-MIRM-3-LED-04-50 16' MOUNTING HEIGHT	38

NOTES
 1. ALL CABLES AND WIRING SHALL BE INSTALLED UNDERGROUND IN CONDUIT. CONDUIT SHALL BE SCHEDULE 40 PVC CONDUIT INSTALLED WITH TWO (2) FEET OF COVER. MINIMUM SIZE OF CONDUIT SHALL BE TWO (2) INCH DIAMETER.

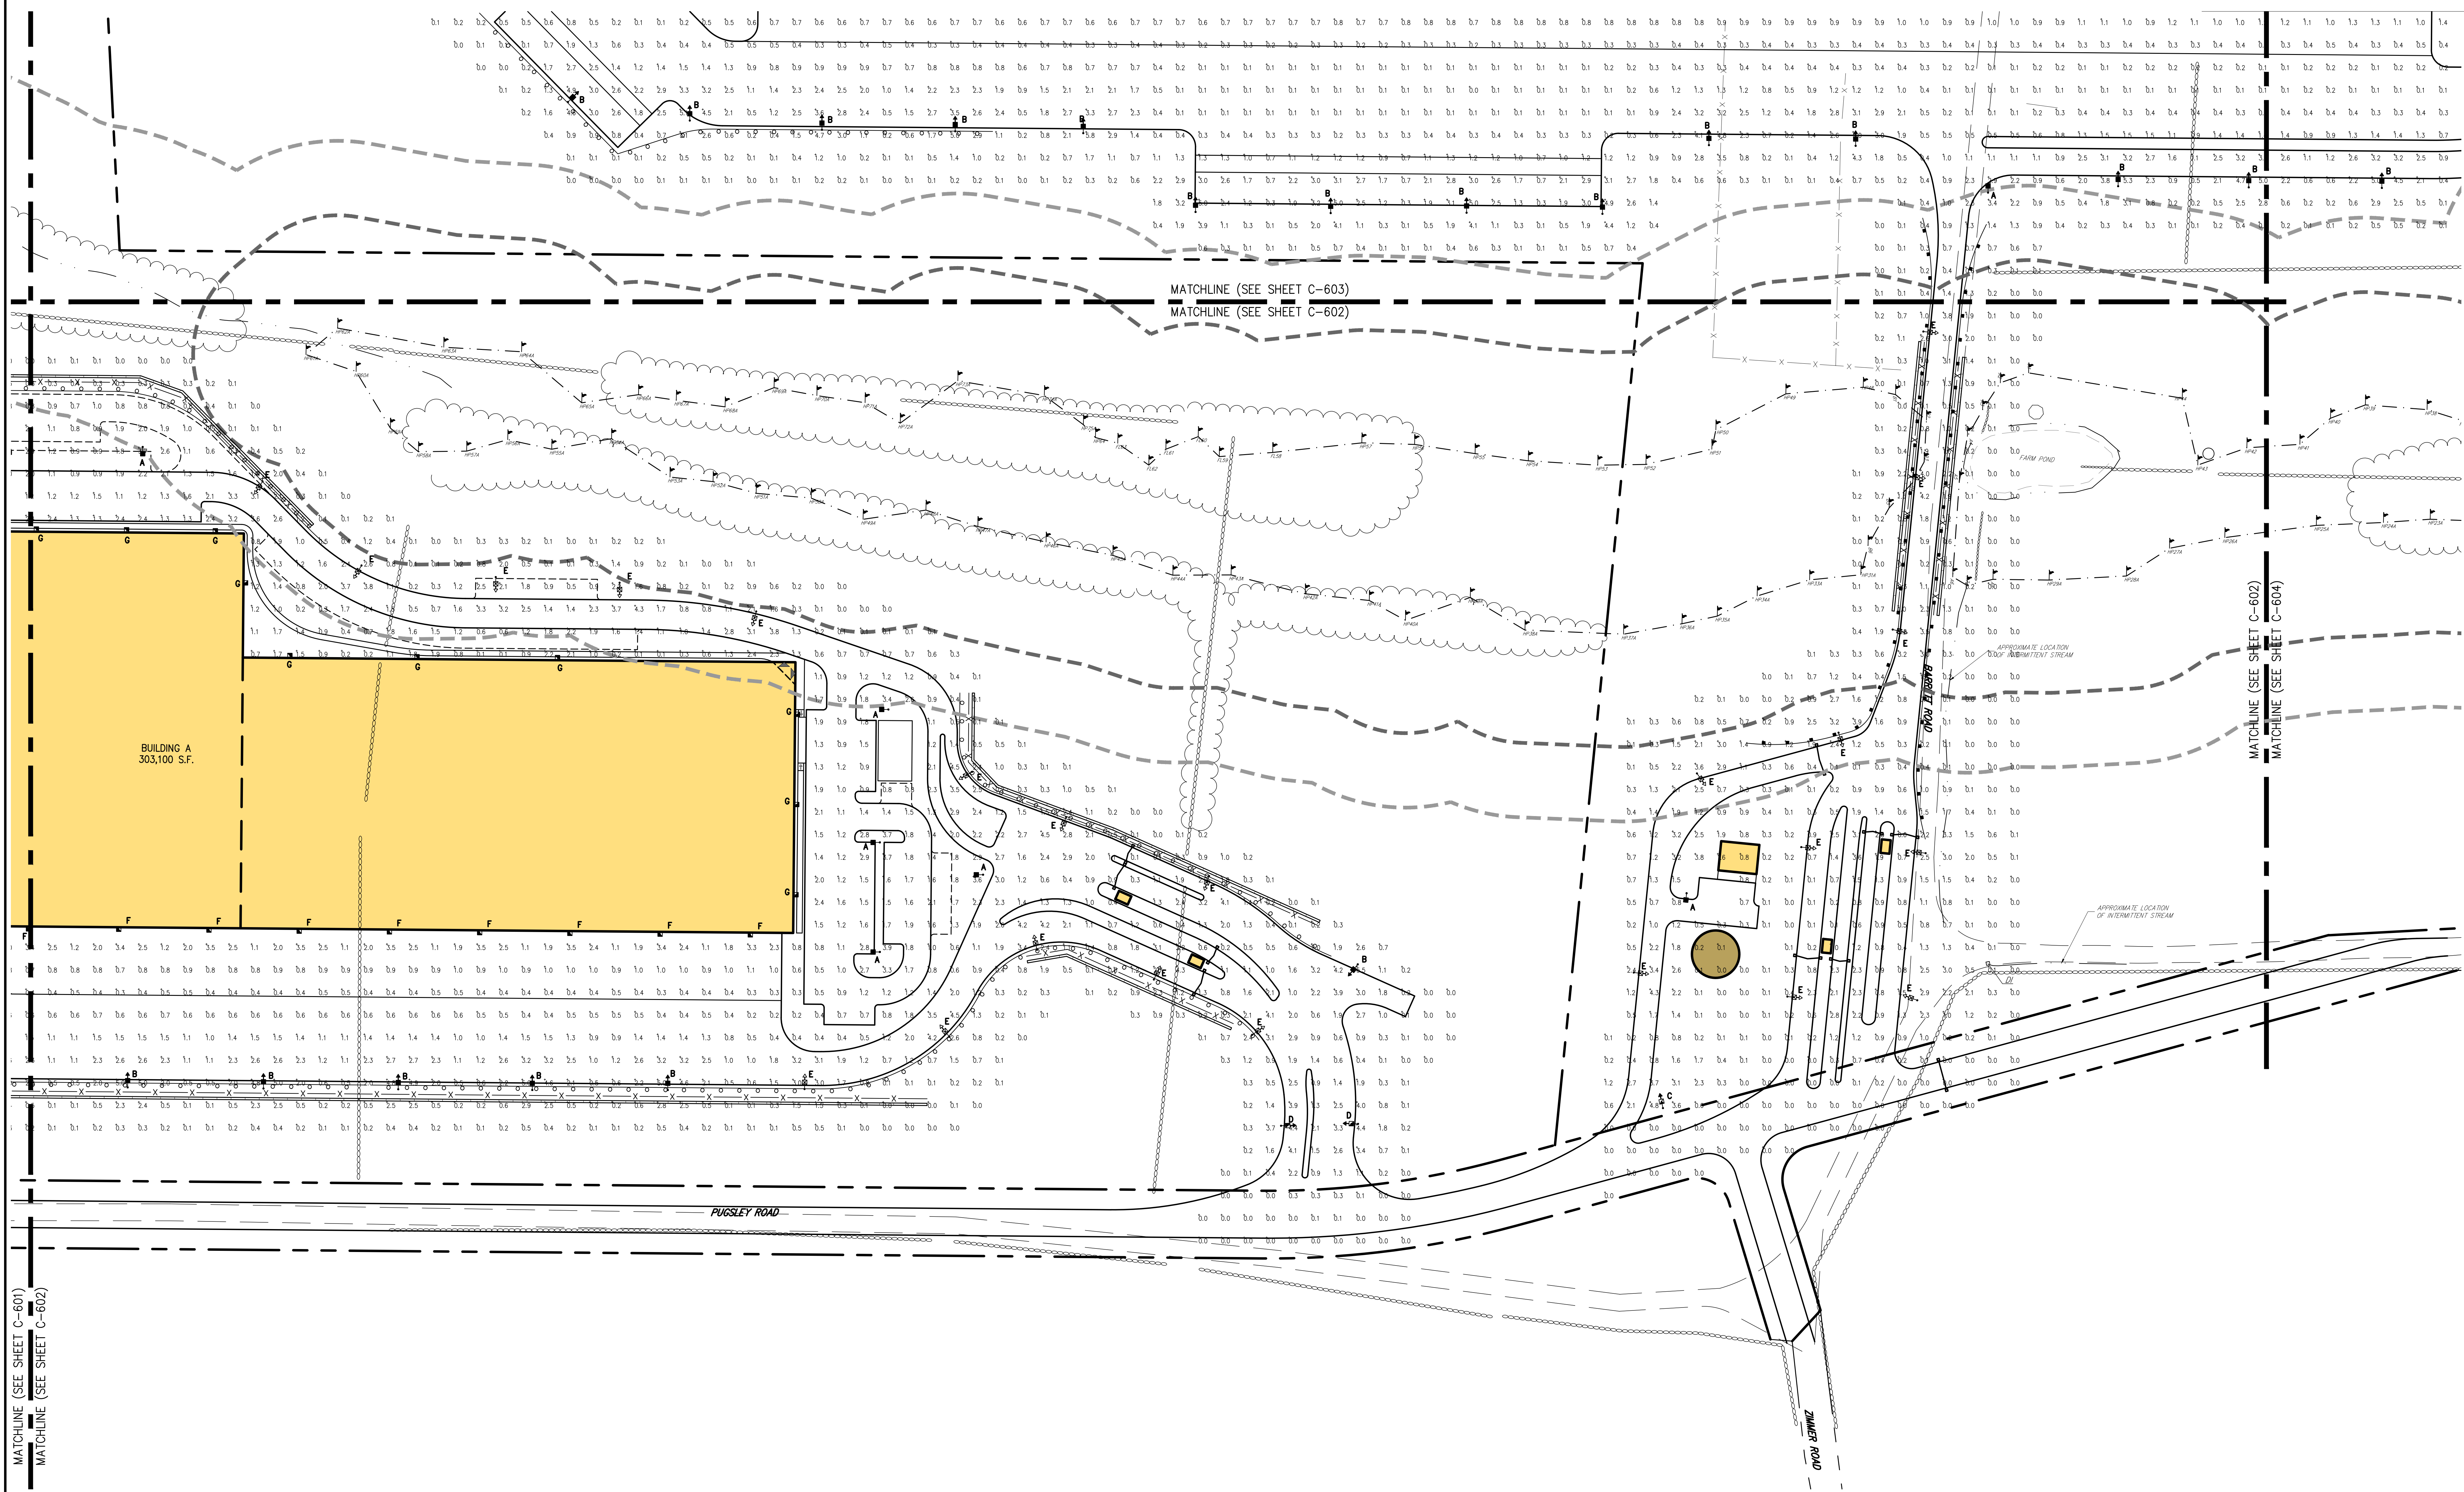


NOT FOR CONSTRUCTION
 MATCHLINE (SEE SHEET C-601)
 MATCHLINE (SEE SHEET C-602)

No.	Date	Revision
1	05/17/2018	ISSUE FOR PERMIT SUBMISSION
2	05/18/2018	ISSUE FOR PERMIT SUBMISSION

APPLICANT:
PUTNAM SEABURY PARTNERS, L.P.
 287 KING STREET
 CHAPPAQUA, NY 10514

JMC Planning, Engineering, Landscape Architecture & Land Surveying, LLC
 JMC Site Development Consultants, LLC
 John Myers Consulting, Inc.
 120 BEAUFORT ROAD - ARMONK, NY 10504
 voice 914.273.5253 fax 914.273.2102
 www.jmcinc.com

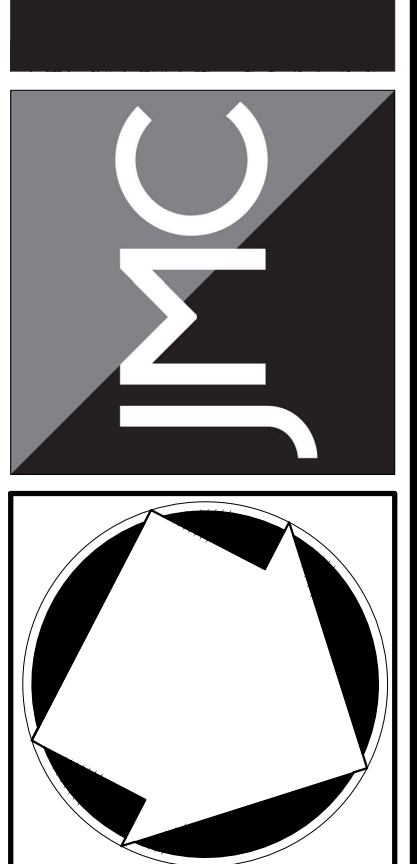

LIGHTING PLAN 'B'
 COMMERCIAL CAMPUS AT FIELDS CORNER
 TOWN OF SOUTHEAST, NEW YORK

ANY ALTERATION OF PLANS, SPECIFICATIONS, PLATS AND REPORTS BEARING THE SEAL OF A LICENSED PROFESSIONAL ENGINEER OR LICENSED LAND SURVEYOR IS A VIOLATION OF SECTION 7209 OF THE NEW YORK STATE EDUCATION LAW EXCEPT AS PROVIDED FOR BY SECTION 7209, SUBSECTION 2.

Drawn: KSM	Approved: RJP
Scale: 1" = 50'	
Date: 11/06/2017	
Project No: 14012	
Sheet No: LIGHTING B (LIGHT PLAN)	
Client: PUTNAM SEABURY PARTNERS, L.P.	

C-602