
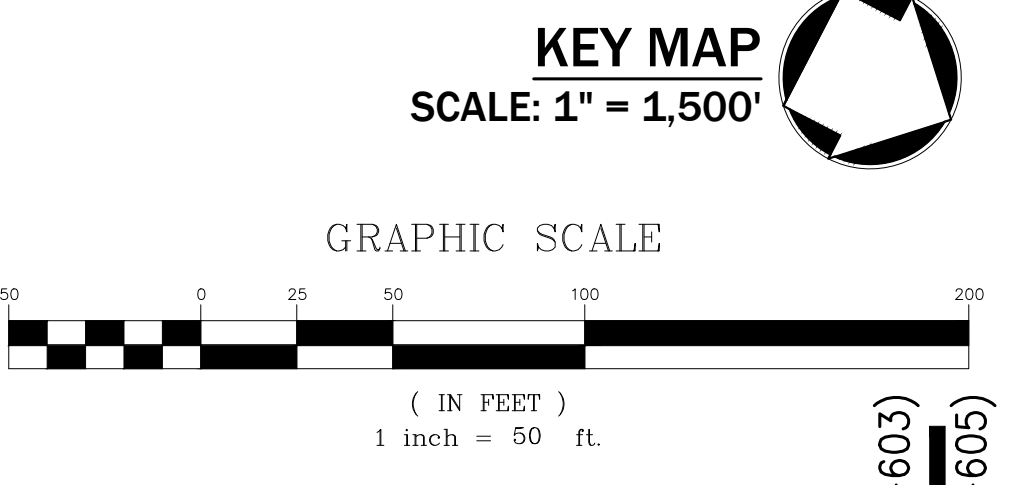



Label	Units	Avg	Max	Min	Avg/Min	Max/Min	PtSpLr	PtSpTb
BUILDING A ENTRANCE	Fc	1.91	4.5	0.1	19.10	45.00	20	20
BUILDING A PARKING	Fc	1.42	5.0	0.1	14.20	50.00		
BUILDING B ENTRANCE	Fc	1.67	4.3	0.1	16.70	43.00		
BUILDING B PARKING	Fc	1.38	5.0	0.0	N.A.	N.A.		

Symbol	Qty	Label	Total Lamp Lumens	LLF	Description	Lum. Watts
●	10	A	N.A.	0.950	WLS-CLXM-LED-18L-SIL-5W-50-70CRI 17' POLE 3' BASE	148.5
●	37	B	N.A.	0.950	WLS-CLXM-LED-18L-SIL-FT-50-70CRI 17' POLE 3' BASE	148.5
●	59	C	N.A.	0.950	WLS-CLXM-LED-18L-SIL-FT-50-70CRI-IL 17' POLE 3' BASE	148.5
●	2	D	N.A.	0.950	WLS-CLXM-LED-12L-SIL-2-50-70CRI 17' POLE 3' BASE	93.1
●	23	E	N.A.	0.950	WLS-CLXM-LED-12L-SIL-3-50-70CRI 17' POLE 3' BASE	93.1
●	42	F	N.A.	0.950	WLS-MIRM-FT-LED-08-50-DIM 16' MOUNTING HEIGHT	76
●	18	G	N.A.	0.950	WLS-MIRM-3-LED-04-50 16' MOUNTING HEIGHT	38

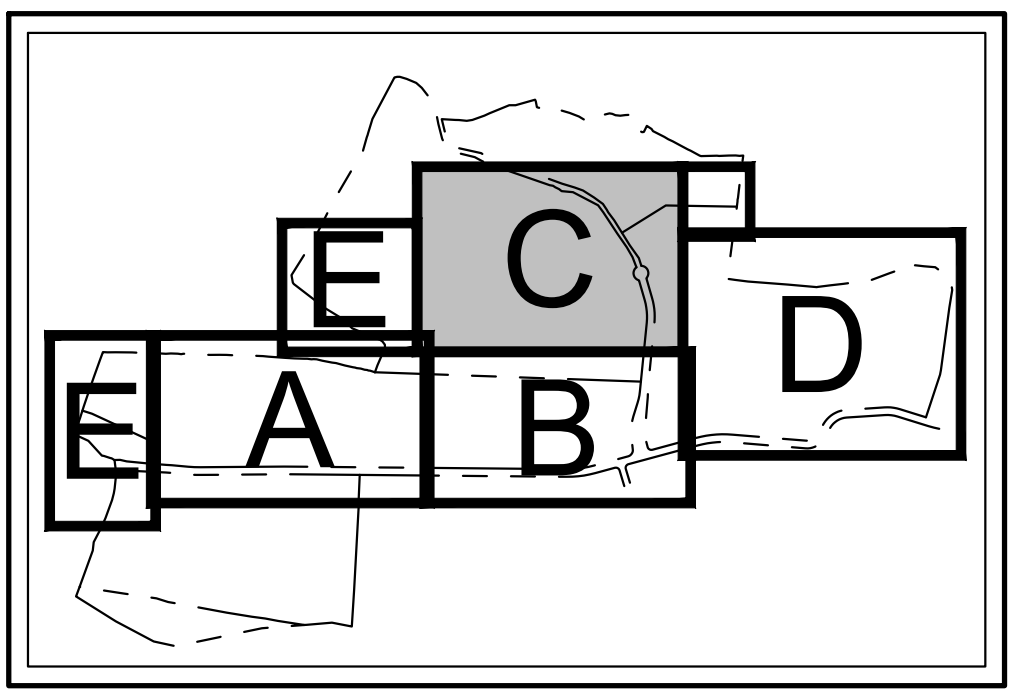

NOTES

- ALL CABLES AND WIRING SHALL BE INSTALLED UNDERGROUND IN CONDUIT. CONDUIT SHALL BE SCHEDULE 40 PVC CONDUIT INSTALLED WITH TWO (2) FEET COVER. MINIMUM SIZE OF CONDUIT SHALL BE TWO (2) INCH DIAMETER.

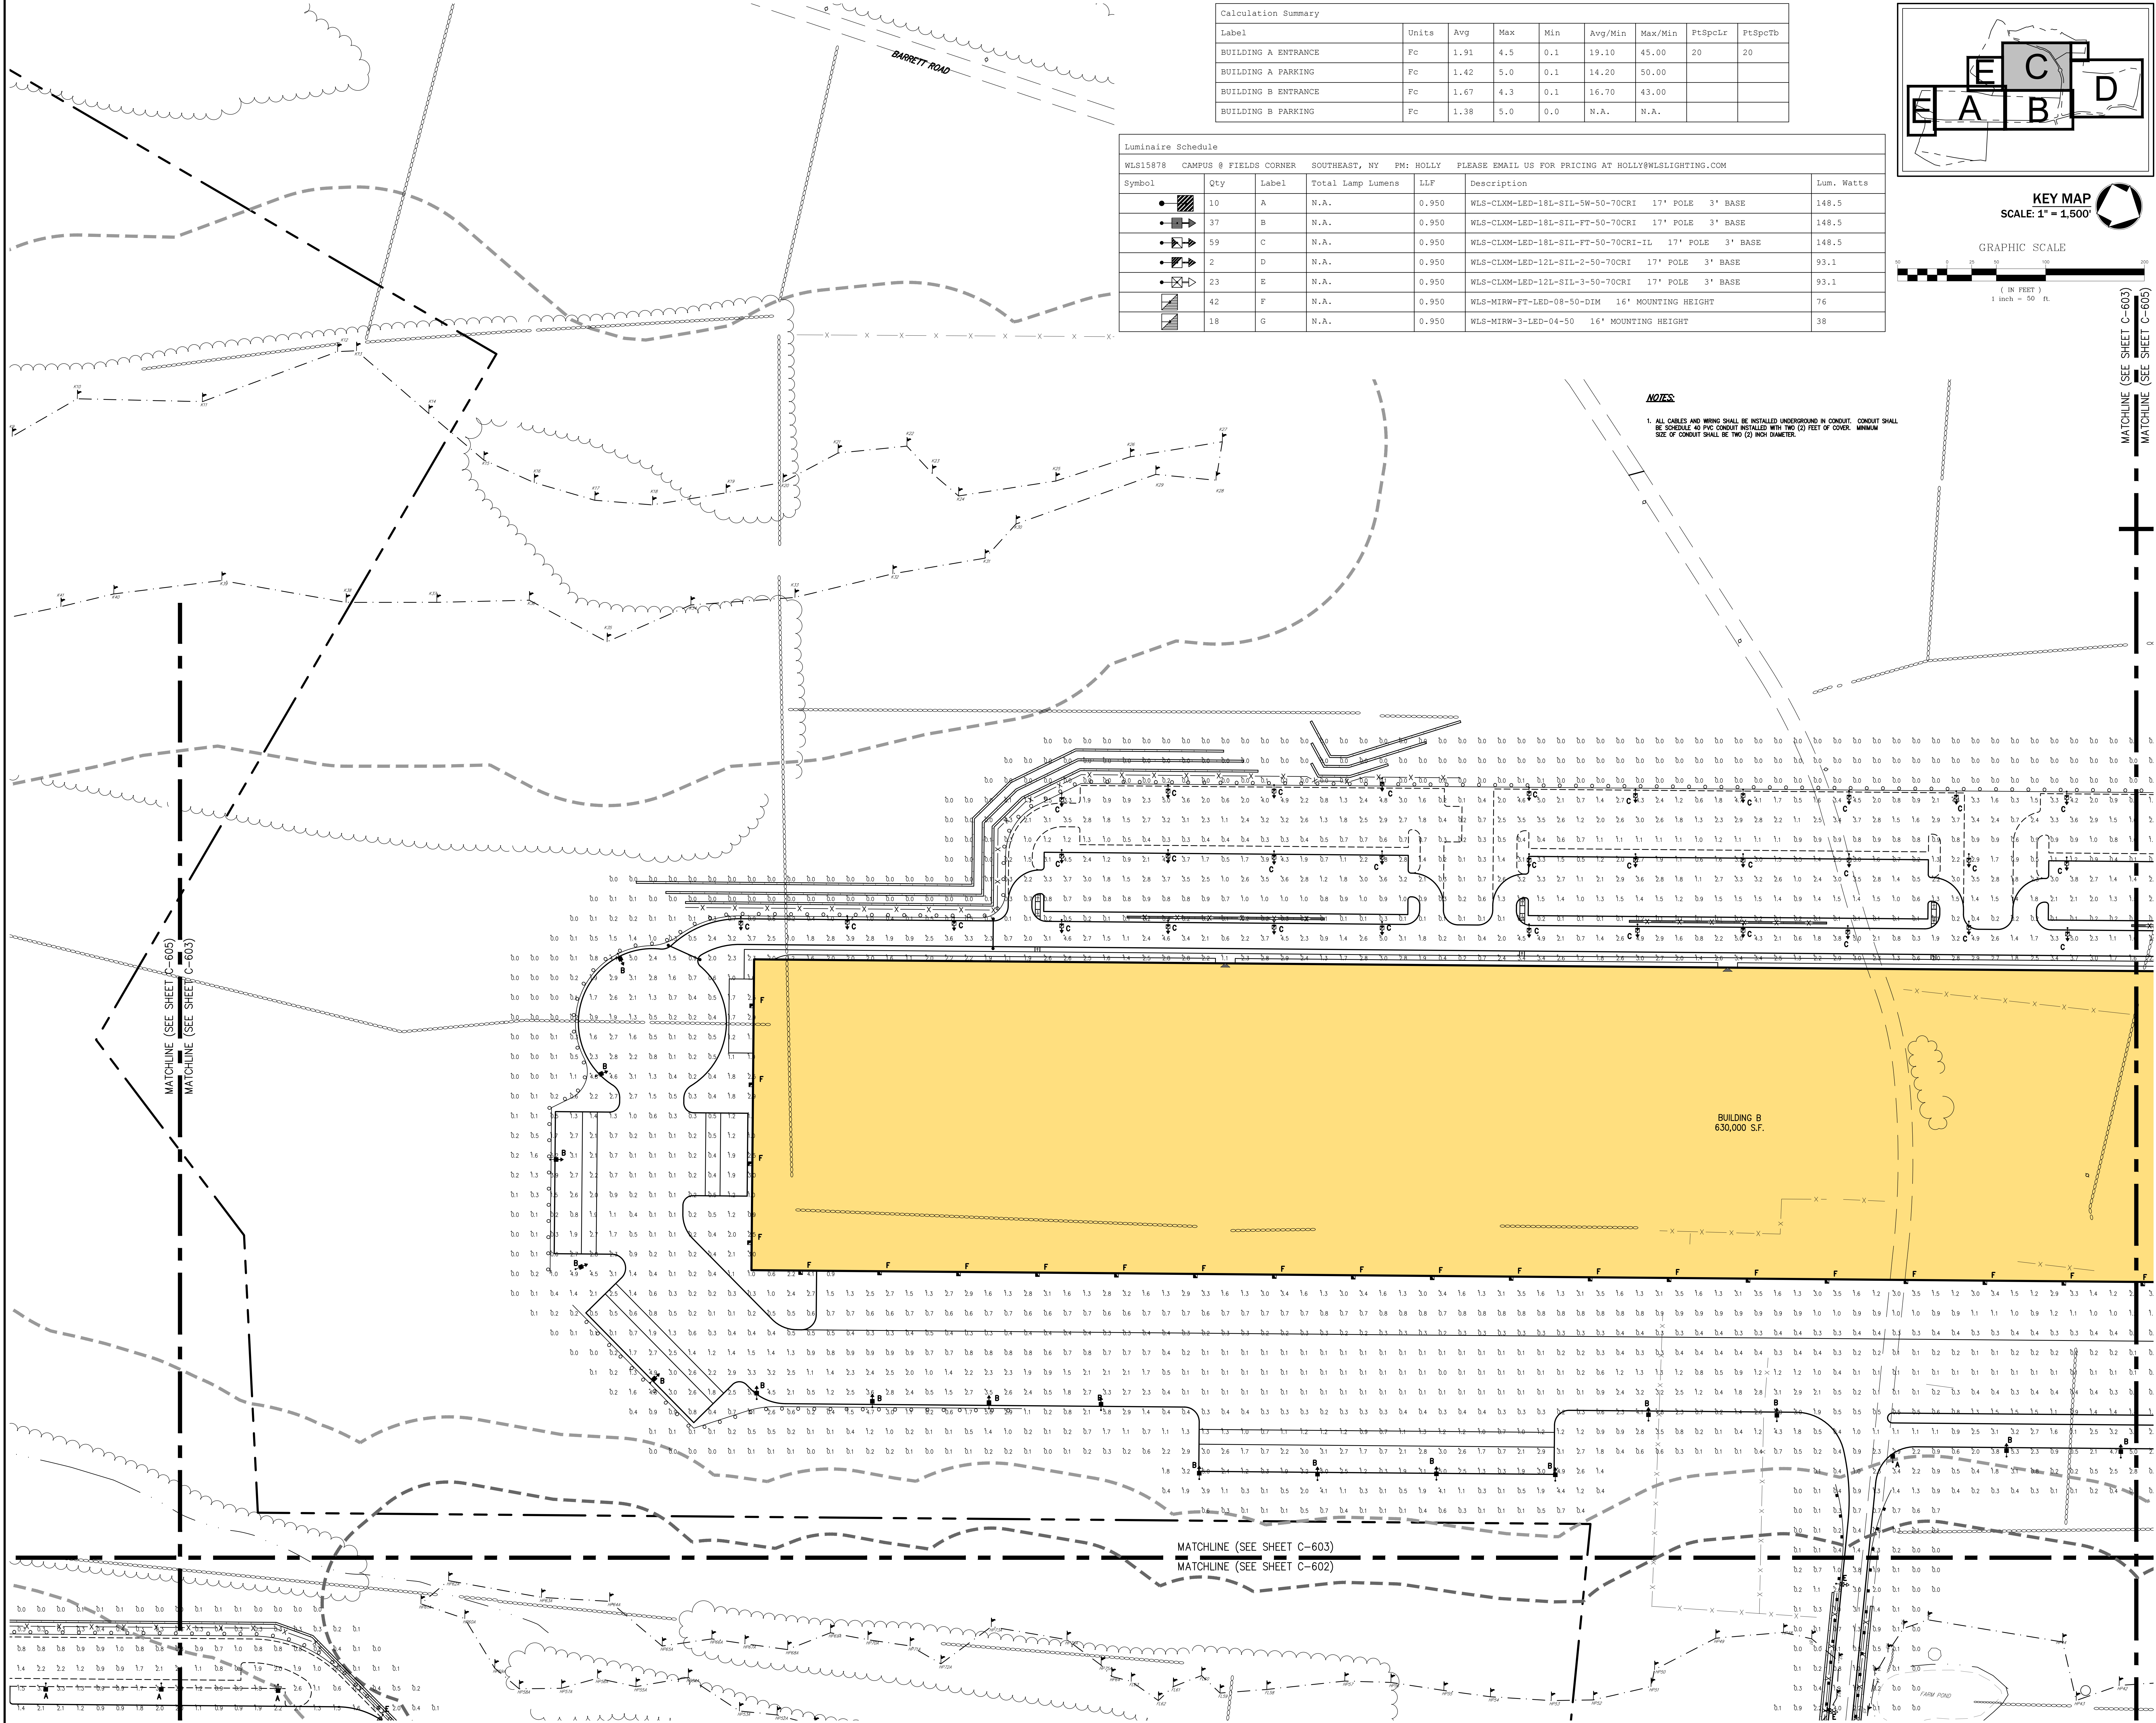

APPLICANT/OWNER: PUTNAM SEABURY PARTNERS, L.P.
287 KING STREET
CHAPPAQUA, NY 10514

REVISIONS:

No.	Date	By	Rev
1.	05/17/2018	SRM/SSM	1
2.	05/18/2018	SRM	2

DESIGNER: JMC Planning, Engineering, Landscape Architecture & Land Surveying, LLC
120 BEAUFORT ROAD - ARMONK, NY 10504
VOICE: 914.233.5235 FAX: 914.273.2192
WWW.JMCPINC.COM

JMC Planning, Engineering, Landscape Architecture & Land Surveying, LLC
JMC Site Development Consultants, LLC
John Meyer Consulting, Inc.
120 BEAUFORT ROAD - ARMONK, NY 10504
VOICE: 914.233.5235 FAX: 914.273.2192
WWW.JMCPINC.COM

JMC

LIGHTING PLAN 'C'
COMMERCIAL CAMPUS AT FIELDS CORNER
TOWN OF SOUTHEAST, NEW YORK

ANY ALTERATION OF PLANS, SPECIFICATIONS, PLATS AND REPORTS BEARING THE SEAL OF A LICENSED PROFESSIONAL ENGINEER OR LICENSED LAND SURVEYOR IS A VIOLATION OF SECTION 7209 OF THE NEW YORK STATE EDUCATION LAW EXCEPT AS PROVIDED FOR BY SECTION 7209.3 SUBSECTION 2.

Drawn: KSM Approved: RJP
Scale: 1" = 50'
Date: 11/06/2017
Project No: 14012
Title: LIGHTING PLAN
Drawing No: C-603

NOT FOR CONSTRUCTION