
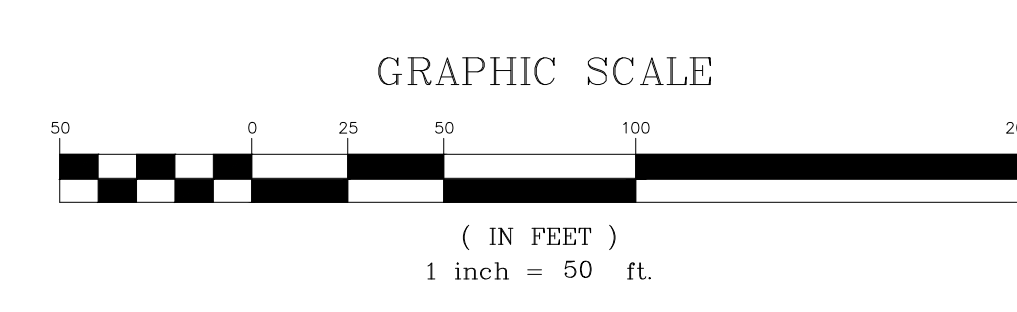
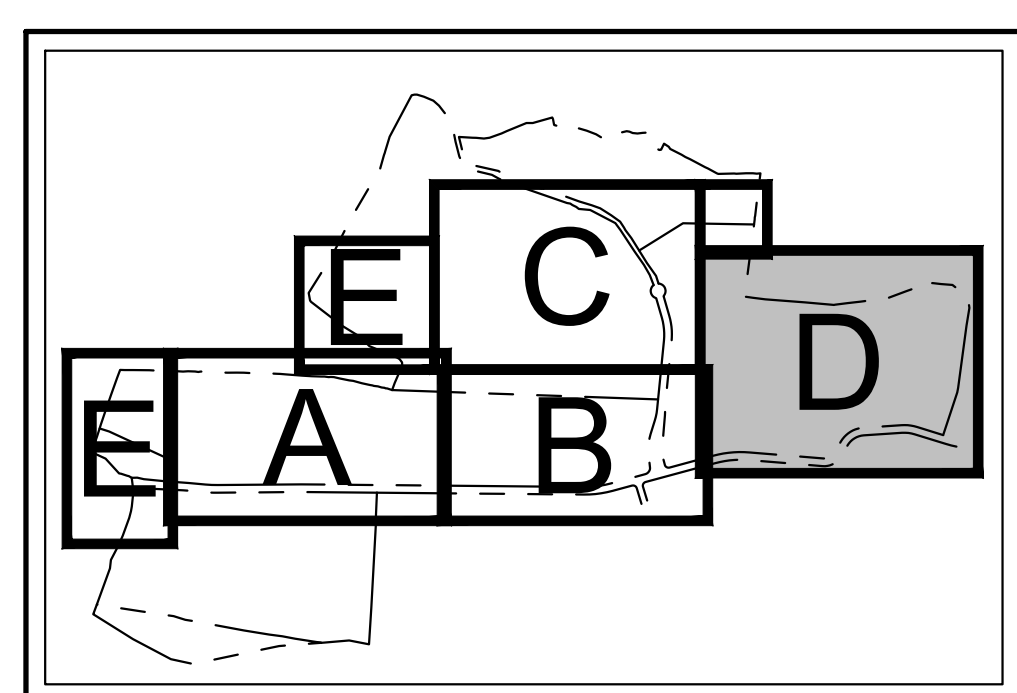


MATCHLINE (SEE SHEET C-603)
MATCHLINE (SEE SHEET C-602)

Calculation Summary								
Label	Units	Avg	Max	Min	Avg/Min	Max/Min	PtSpcLr	PtSpcTb
BUILDING A ENTRANCE	Fc	1.91	4.5	0.1	19.10	45.00	20	20
BUILDING A PARKING	Fc	1.42	5.0	0.1	14.20	50.00		
BUILDING B ENTRANCE	Fc	1.67	4.3	0.1	16.70	43.00		
BUILDING B PARKING	Fc	1.38	5.0	0.0	N.A.	N.A.		

Luminaire Schedule								
Symbol	Qty	Label	Total Lamp Lumens	LLF	Description			Lum. Watts
●	10	A	N.A.	0.950	WLS-CLXM-LED-18L-SIL-SW-50-70CRI	17' POLE	3' BASE	148.5
●	37	B	N.A.	0.950	WLS-CLXM-LED-18L-SIL-FT-50-70CRI	17' POLE	3' BASE	148.5
●	59	C	N.A.	0.950	WLS-CLXM-LED-18L-SIL-FT-50-70CRI-IL	17' POLE	3' BASE	148.5
●	2	D	N.A.	0.950	WLS-CLXM-LED-12L-SIL-2-50-70CRI	17' POLE	3' BASE	93.1
●	23	E	N.A.	0.950	WLS-CLXM-LED-12L-SIL-3-50-70CRI	17' POLE	3' BASE	93.1
■	42	F	N.A.	0.950	WLS-MIRW-FT-LED-08-50-DIM	16' MOUNTING HEIGHT		76
■	18	G	N.A.	0.950	WLS-MIRW-3-LED-04-50	16' MOUNTING HEIGHT		38

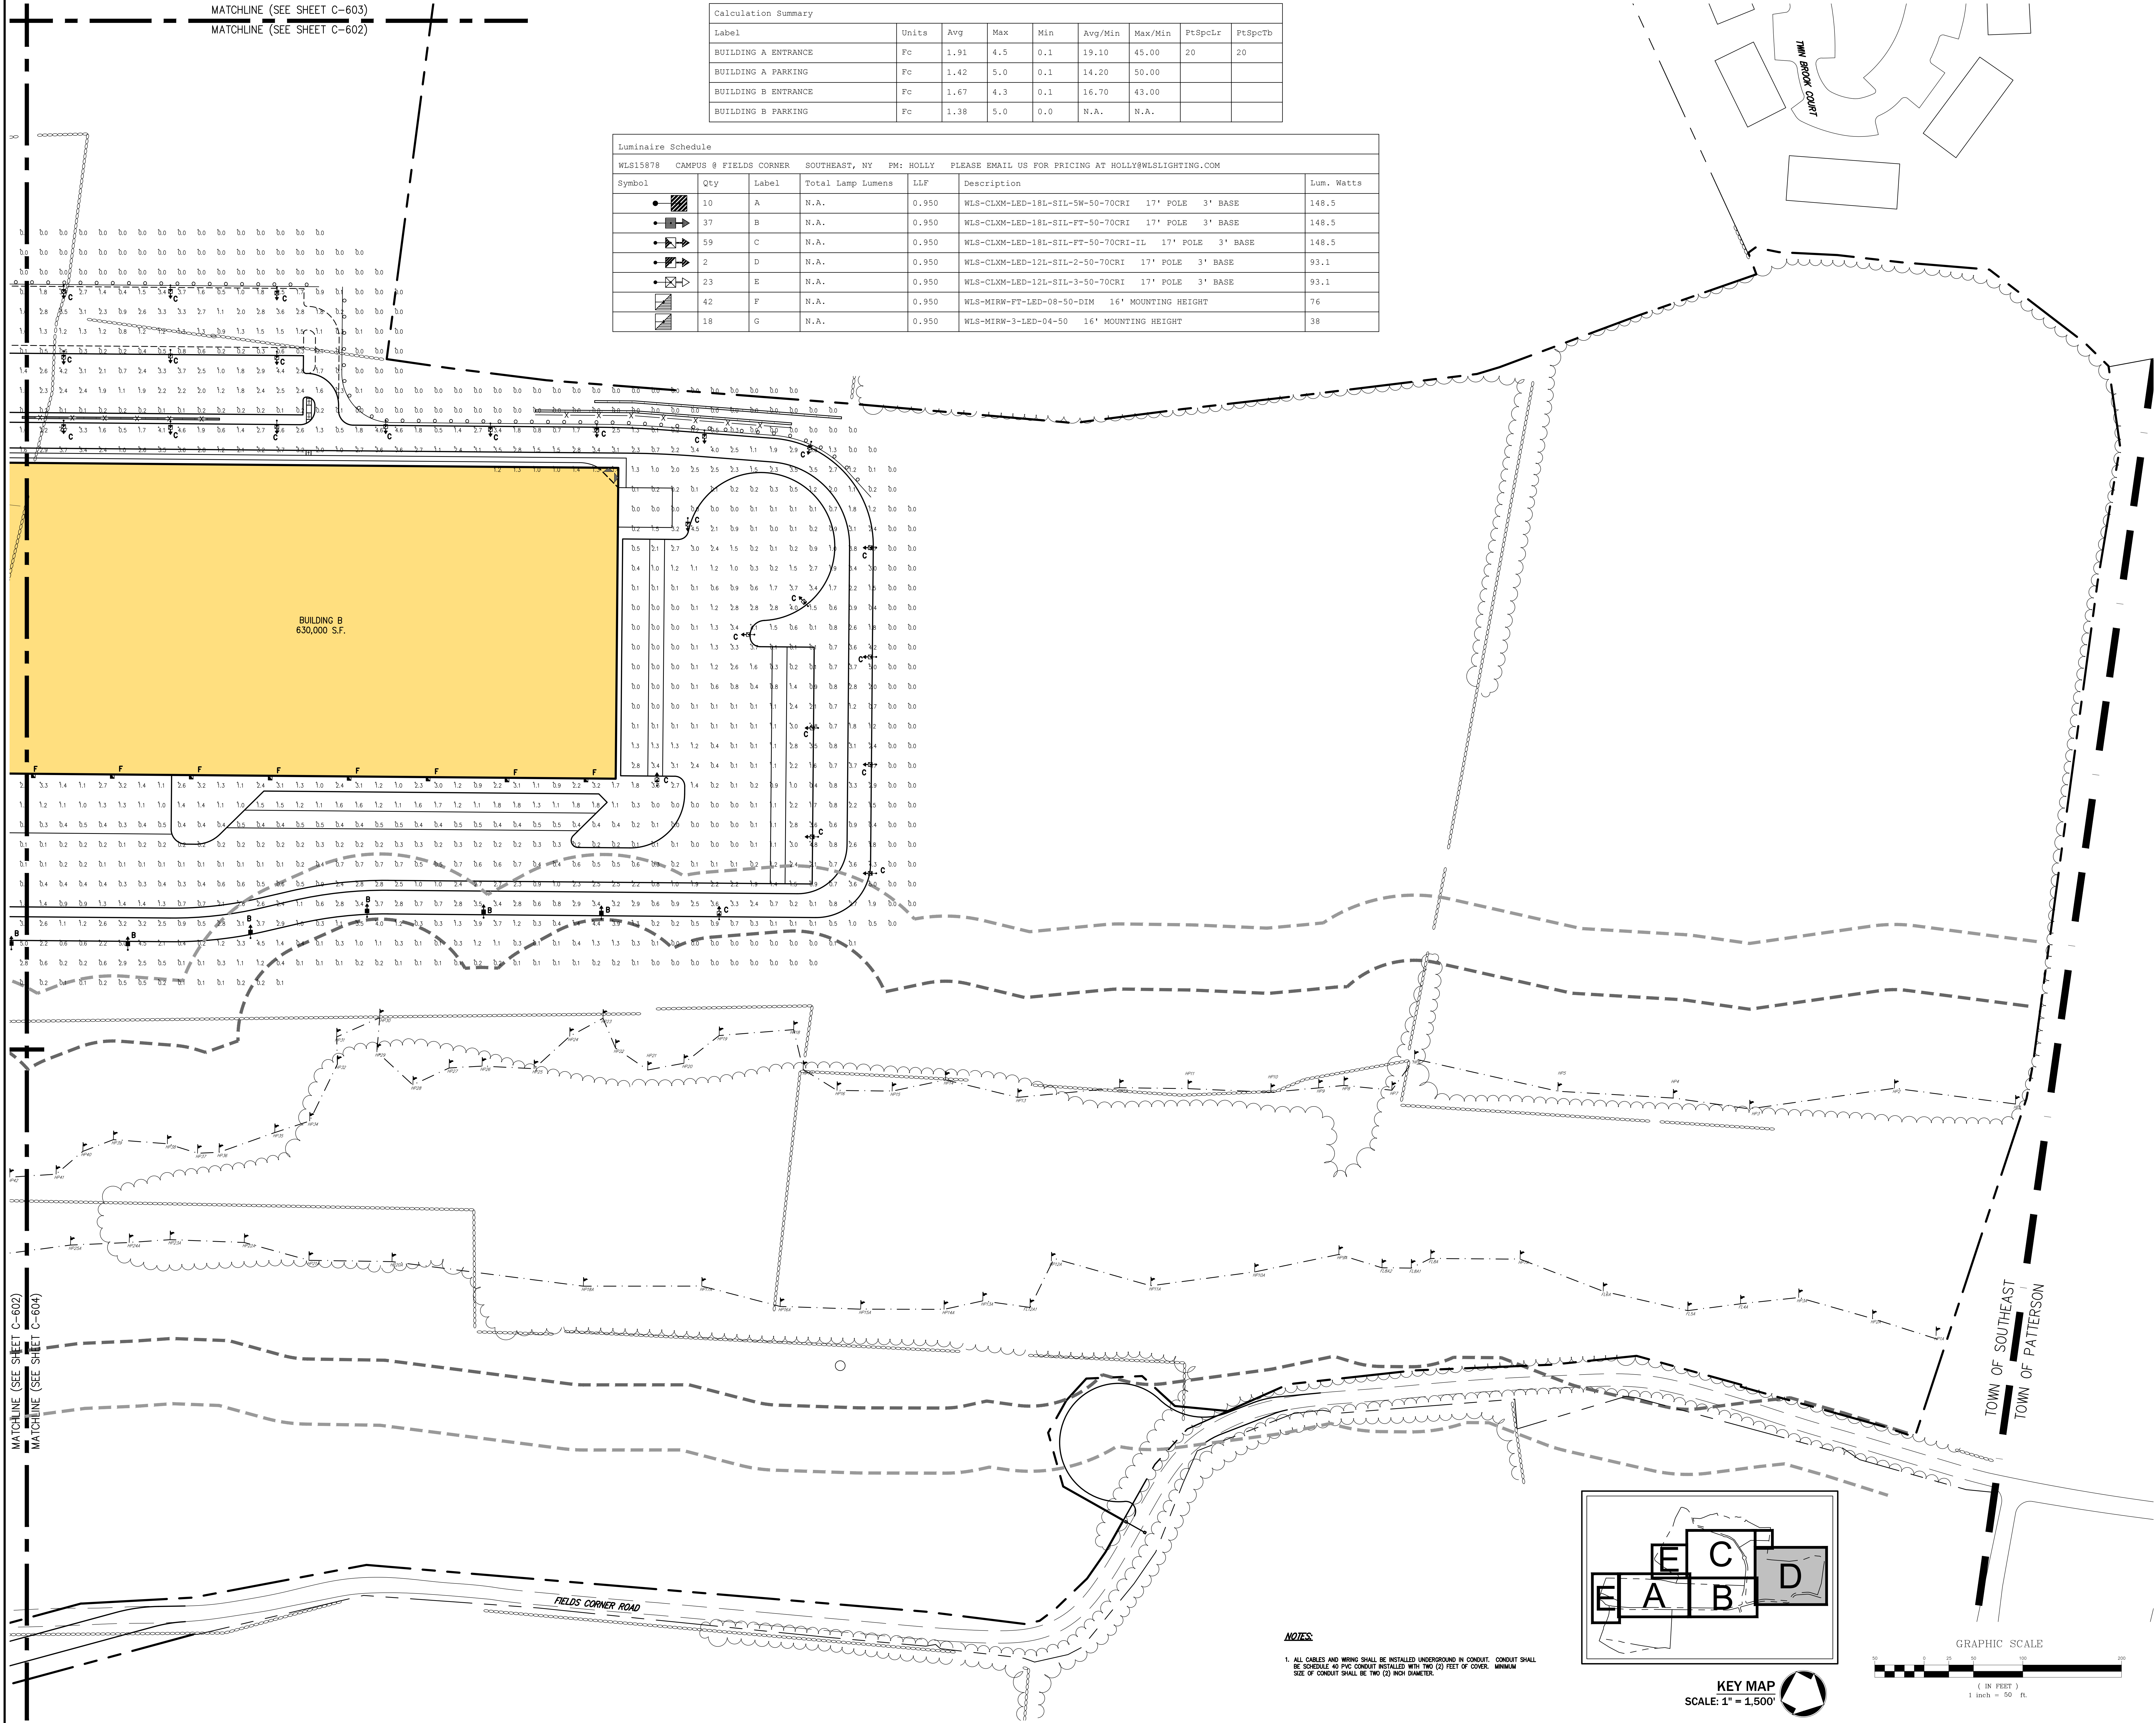

NOTES
1. ALL CABLES AND WIRING SHALL BE INSTALLED UNDERGROUND IN CONDUIT. CONDUIT SHALL BE SCHEDULE 40 PVC CONDUIT INSTALLED WITH TWO (2) FEET OF COVER. MINIMUM SIZE OF CONDUIT SHALL BE TWO (2) INCH DIAMETER.

NOT FOR CONSTRUCTION

MATCHLINE (SEE SHEET C-602)
MATCHLINE (SEE SHEET C-604)

<p>APPLICANT/TOWNER:</p> <p>PUTNAM SEABURY PARTNERS, L.P. 287 KING STREET CHAPPAQUA, NY 10514</p>	<p>Revision:</p> <table border="1" style="width: 100%; border-collapse: collapse;"> <thead> <tr> <th>No.</th> <th>Description</th> <th>Date</th> </tr> </thead> <tbody> <tr> <td>1.</td> <td>DES. COMPLETENESS SUBMISSION</td> <td>05/17/2018</td> </tr> <tr> <td>2.</td> <td>FIS. COMPLETENESS SUBMISSION</td> <td>03/18/2019</td> </tr> </tbody> </table>	No.	Description	Date	1.	DES. COMPLETENESS SUBMISSION	05/17/2018	2.	FIS. COMPLETENESS SUBMISSION	03/18/2019
No.	Description	Date								
1.	DES. COMPLETENESS SUBMISSION	05/17/2018								
2.	FIS. COMPLETENESS SUBMISSION	03/18/2019								
<p>LIGHTING PLAN 'D' COMMERCIAL CAMPUS AT FIELDS CORNER TOWN OF SOUTHEAST, NEW YORK</p>										
<p>ANY ALTERATION OF PLANS, SPECIFICATIONS, PLATS AND REPORTS BEARING THE SEAL OF A LICENSED PROFESSIONAL ENGINEER OR LICENSED LAND SURVEYOR IS A VIOLATION OF SECTION 7209 OF THE NEW YORK STATE EDUCATION LAW, EXCEPT AS PROVIDED FOR BY SECTION 7209, SUBSECTION 2.</p>										
<p>Drawn: KSM Approved: R.P.</p> <p>Scale: 1" = 50'</p> <p>Date: 11/06/2017</p> <p>Project No: 14012</p> <p>Sheet No: LIGHTING D (LIGHTING)</p>	<p>C-604</p>									