

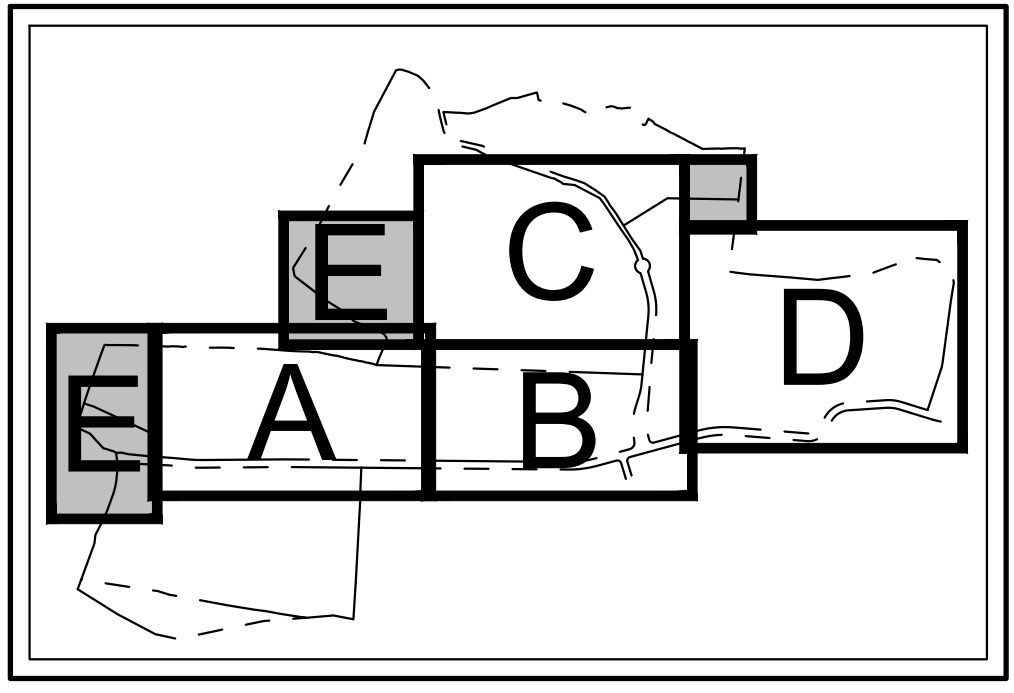


| Calculation Summary | | | | | | | | |
|---------------------|-------|------|-----|-----|---------|---------|---------|---------|
| Label | Units | Avg | Max | Min | Avg/Min | Max/Min | FtSpcLr | FtSpcTb |
| BUILDING A ENTRANCE | Fc | 1.91 | 4.5 | 0.1 | 19.10 | 45.00 | 20 | 20 |
| BUILDING A PARKING | Fc | 1.42 | 5.0 | 0.1 | 14.20 | 50.00 | | |
| BUILDING B ENTRANCE | Fc | 1.67 | 4.3 | 0.1 | 16.70 | 43.00 | | |
| BUILDING B PARKING | Fc | 1.38 | 5.0 | 0.0 | N.A. | N.A. | | |

| Luminaire Schedule | | | | | | | | |
|--------------------|-----|-------|-------------------|-------|--|--|--|------------|
| Symbol | Qty | Label | Total Lamp Lumens | LLF | Description | | | Lum. Watts |
| | 10 | A | N.A. | 0.950 | WLS-CLXM-LED-18L-SIL-5W-50-70CRI 17' POLE 3' BASE | | | 148.5 |
| | 37 | B | N.A. | 0.950 | WLS-CLXM-LED-18L-SIL-FT-50-70CRI 17' POLE 3' BASE | | | 148.5 |
| | 59 | C | N.A. | 0.950 | WLS-CLXM-LED-18L-SIL-FT-50-70CRI-1L 17' POLE 3' BASE | | | 148.5 |
| | 2 | D | N.A. | 0.950 | WLS-CLXM-LED-12L-SIL-2-50-70CRI 17' POLE 3' BASE | | | 93.1 |
| | 23 | E | N.A. | 0.950 | WLS-CLXM-LED-12L-SIL-3-50-70CRI 17' POLE 3' BASE | | | 93.1 |
| | 42 | F | N.A. | 0.950 | WLS-MIRN-FT-LED-08-50-DIM 16' MOUNTING HEIGHT | | | 76 |
| | 18 | G | N.A. | 0.950 | WLS-MIRN-3-LED-04-50 16' MOUNTING HEIGHT | | | 38 |

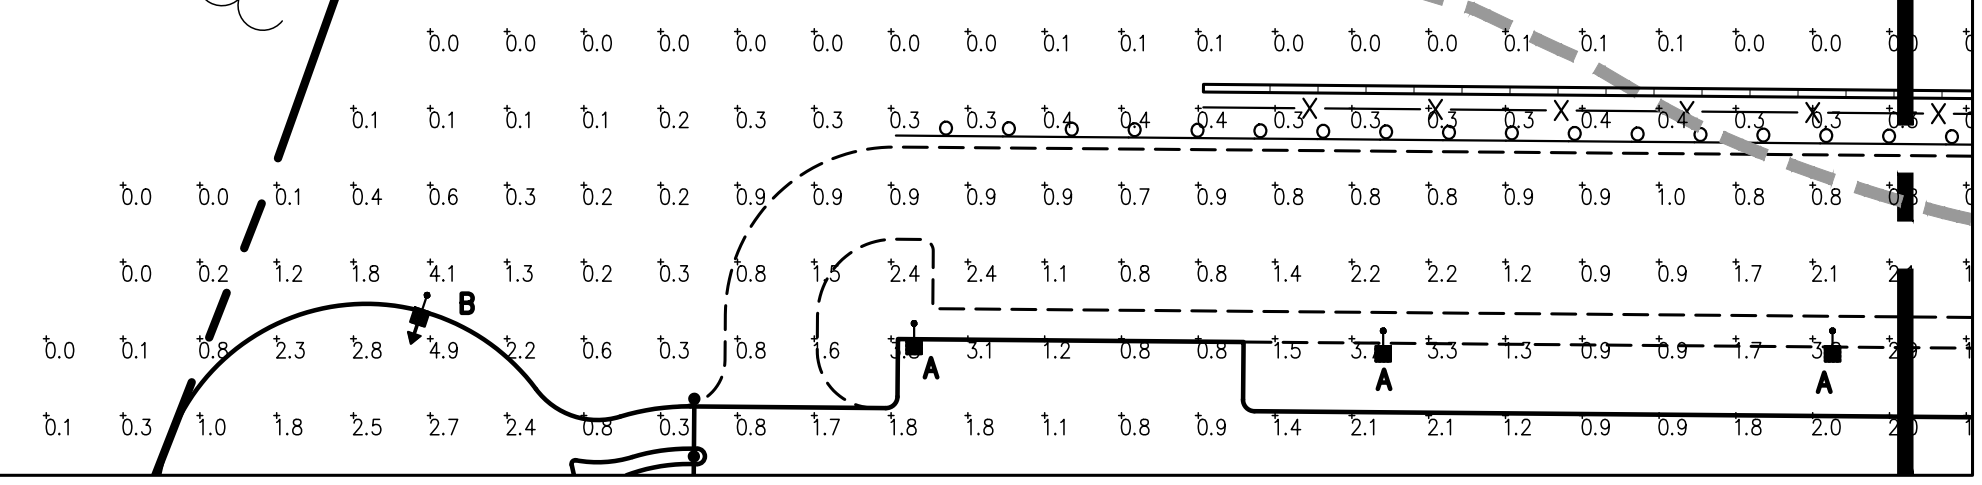

NOTES:
 1. ALL CABLES AND WIRING SHALL BE INSTALLED UNDERGROUND IN CONDUIT. CONDUIT SHALL BE SCHEDULE 40 PVC CONDUIT INSTALLED WITH TWO (2) FEET OF COVER. MINIMUM SIZE OF CONDUIT SHALL BE TWO (2) INCH DIAMETER.

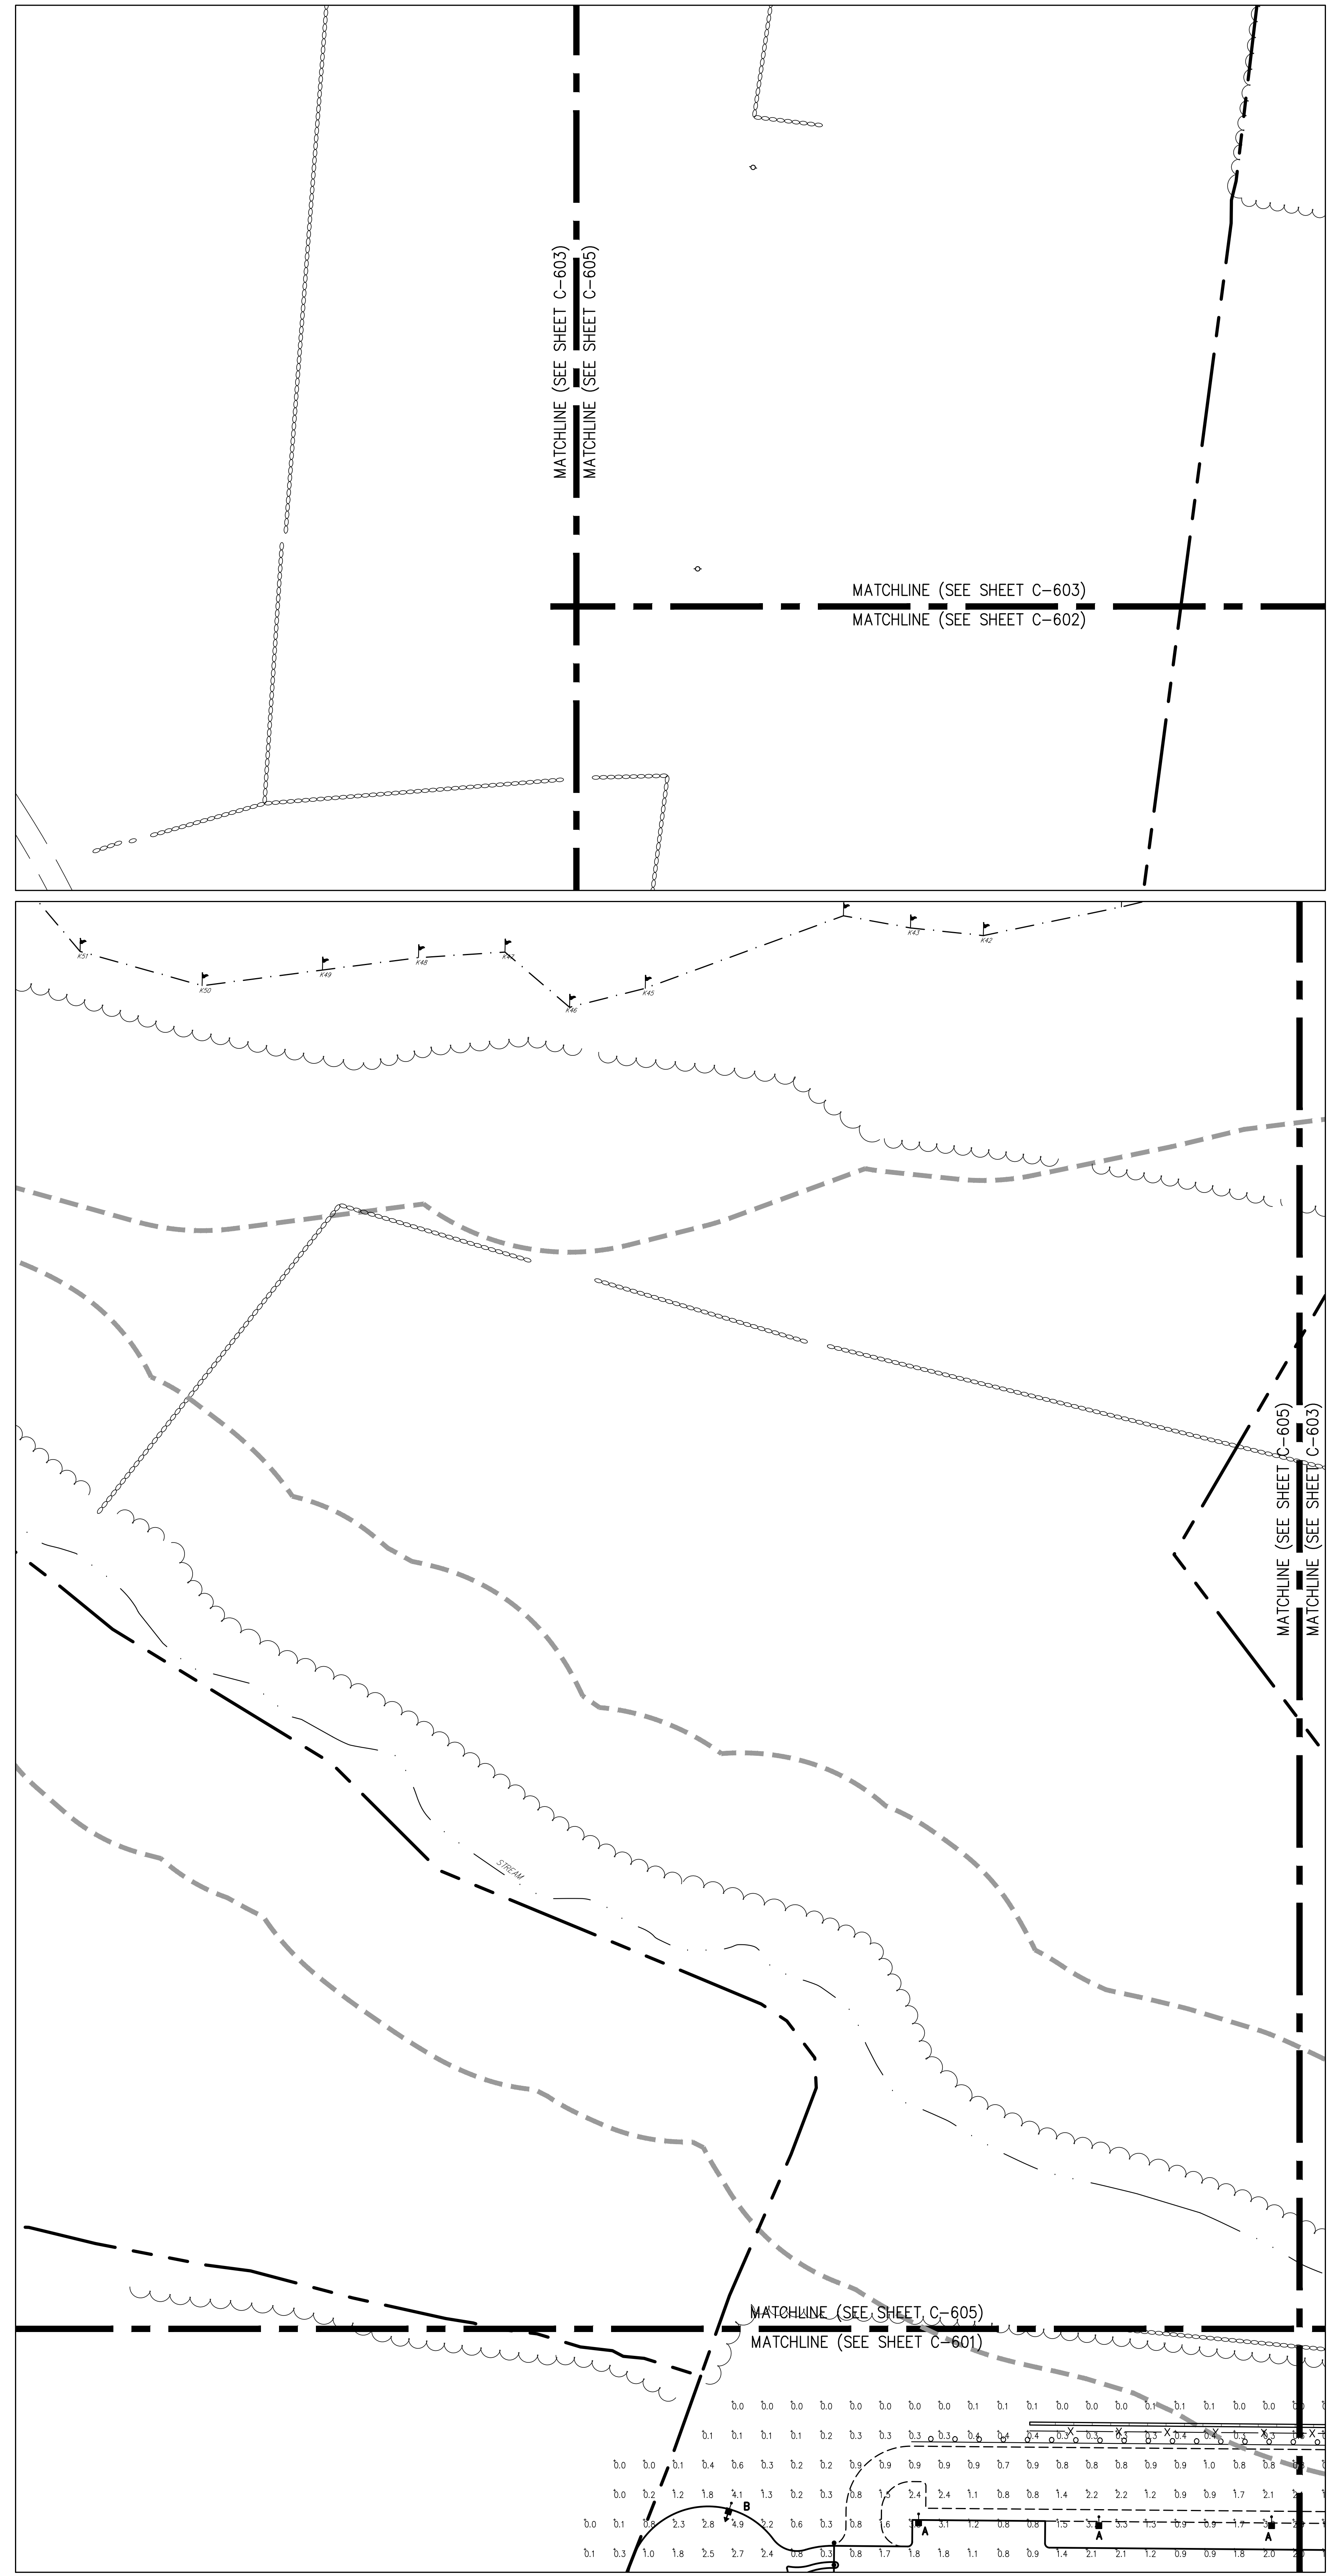

| | | |
|--|---|--------------------------|
| No. 1. THIS COMPLETENESS SUBMISSION 2. THIS COMPLETENESS SUBMISSION | By | KSM |
| | Date | 05/17/2018 05/18/2018 |
| Reason | REVISIONS | |
| APPLICANT/OWNER | PUTNAM SEABURY PARTNERS, L.P. 287 KING STREET CHAPPAQUA, NY 10514 | |
| JMC | JMC Planning, Engineering, Landscape Architecture & Land Surveying, LLC JMC Site Development Consultants, LLC John Meyer Consulting, Inc. 120 BEAUFORT ROAD - WARREN, NY 10594 voice 518.238.5525 • fax 518.272.2102 www.jmcplc.com | |
| LIGHTING PLAN 'E' COMMERCIAL CAMPUS AT FIELDS CORNER TOWN OF SOUTHEAST, NEW YORK | | |
| ANY ALTERATION OF PLANS, SPECIFICATIONS, PLATS AND REPORTS BEARING THE SEAL OF A LICENSED PROFESSIONAL ENGINEER OR LICENSED LAND SURVEYOR IS A VIOLATION OF SECTION 7209 OF THE NEW YORK STATE EDUCATION LAW EXCEPT AS PROVIDED FOR BY SECTION 7209, SUBSECTION 2. | | |
| Drawn | KSM | Approved |
| Scale | 1" = 50' | |
| Date | 11/06/2017 | |
| Project No. | 14012 | |
| Sheet No. | LIGHTING (E) LIGHTING | |
| C-605 | | |

NOT FOR CONSTRUCTION